

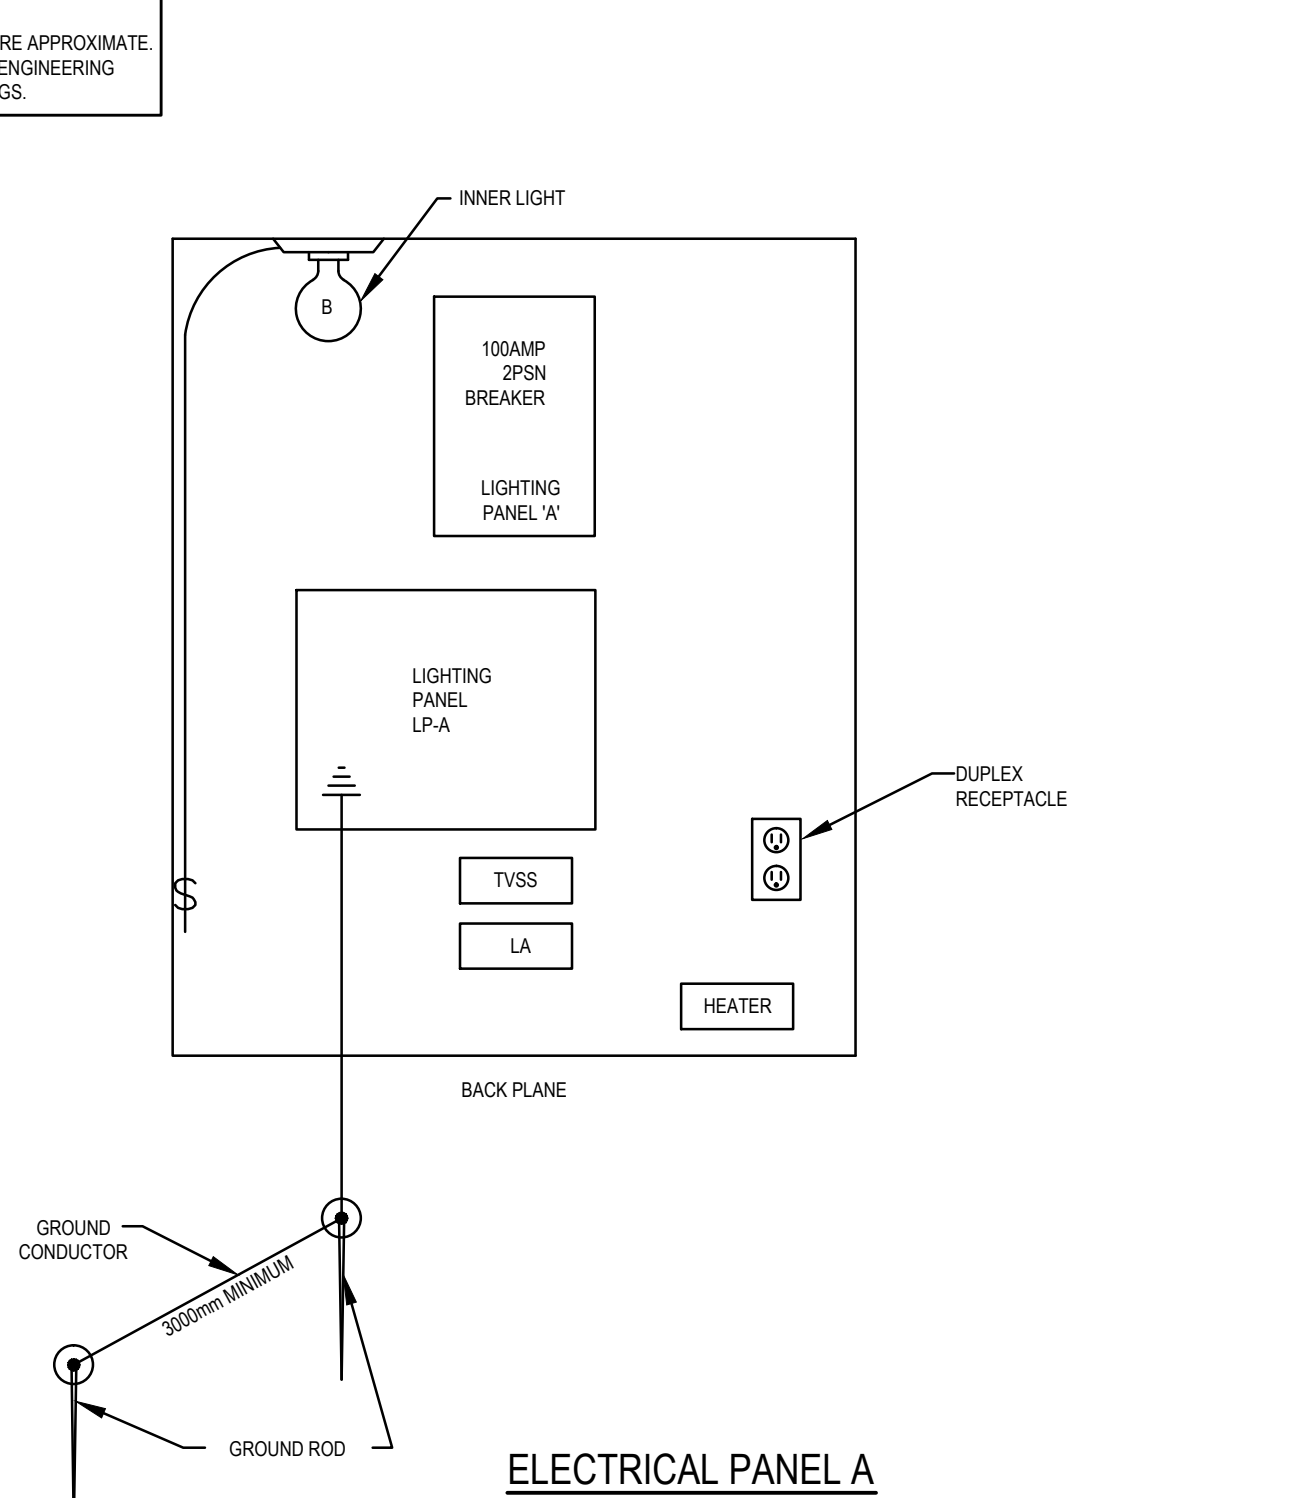
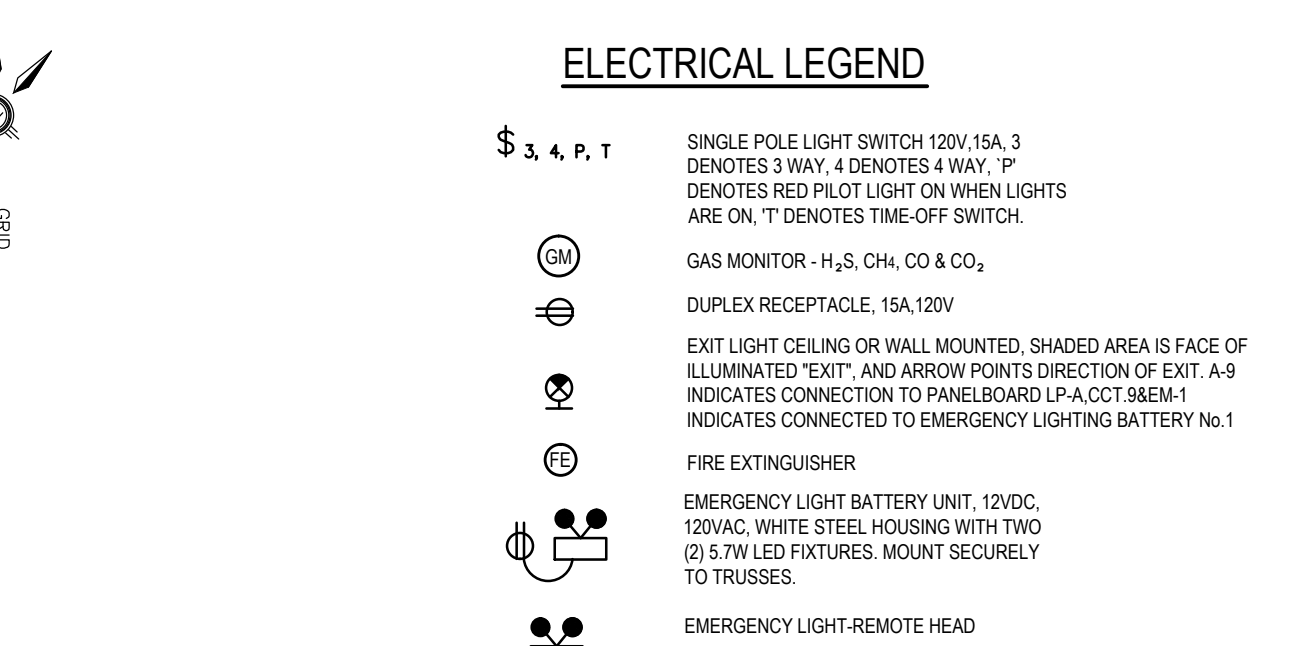
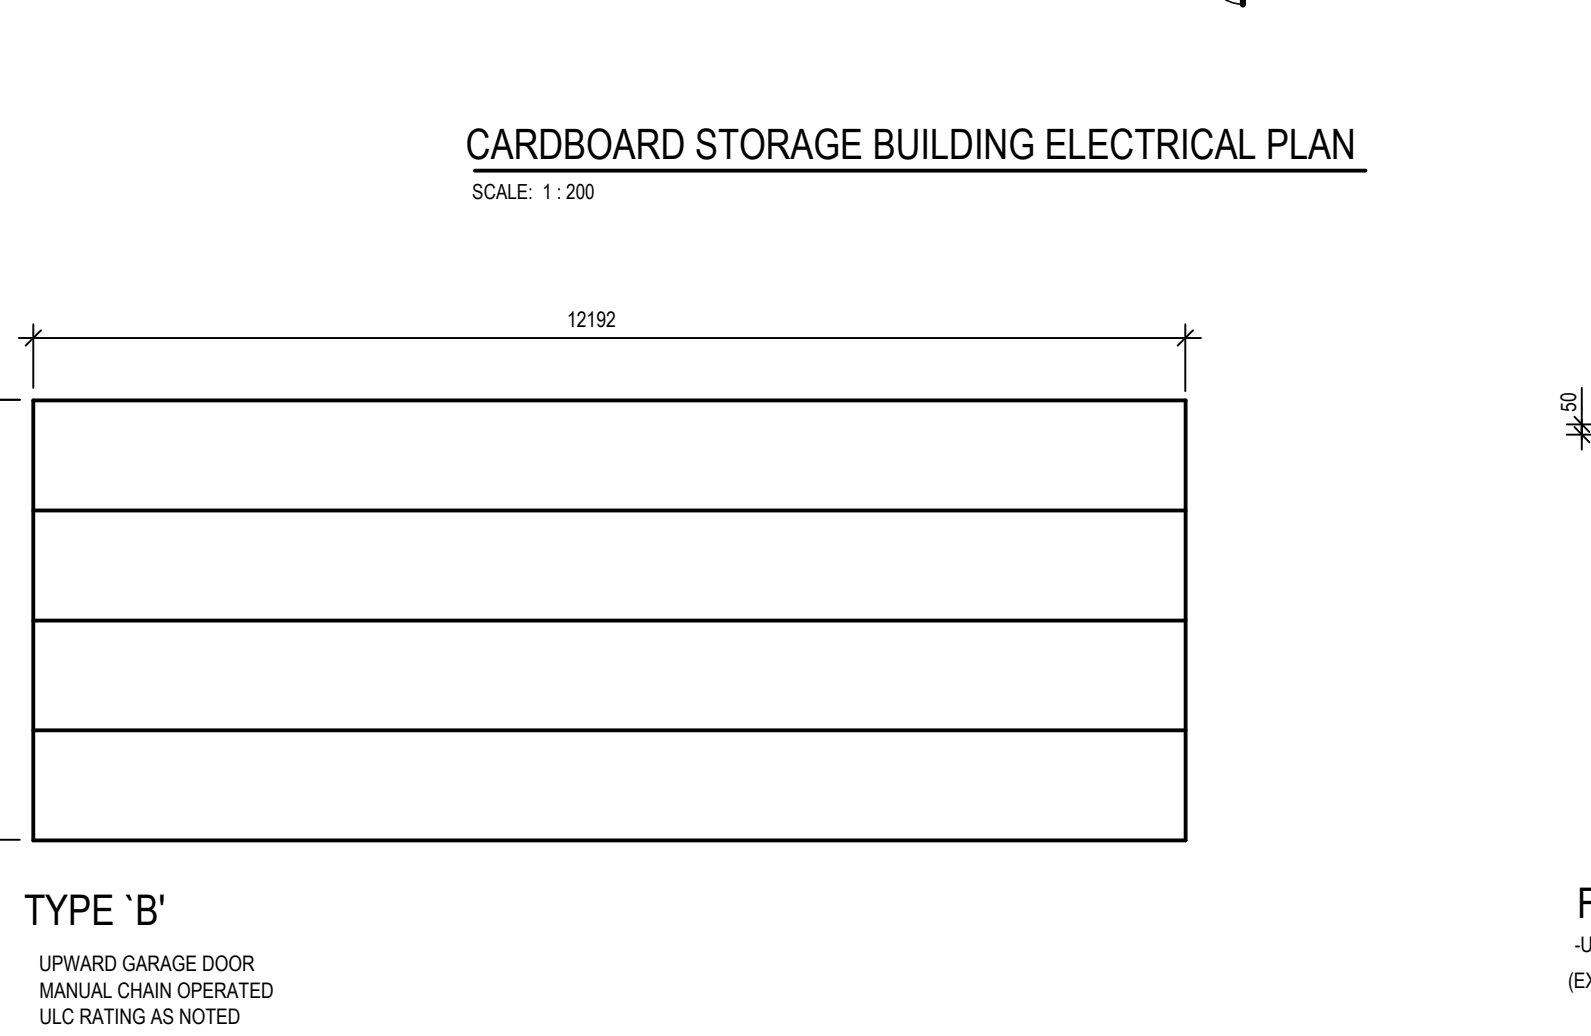
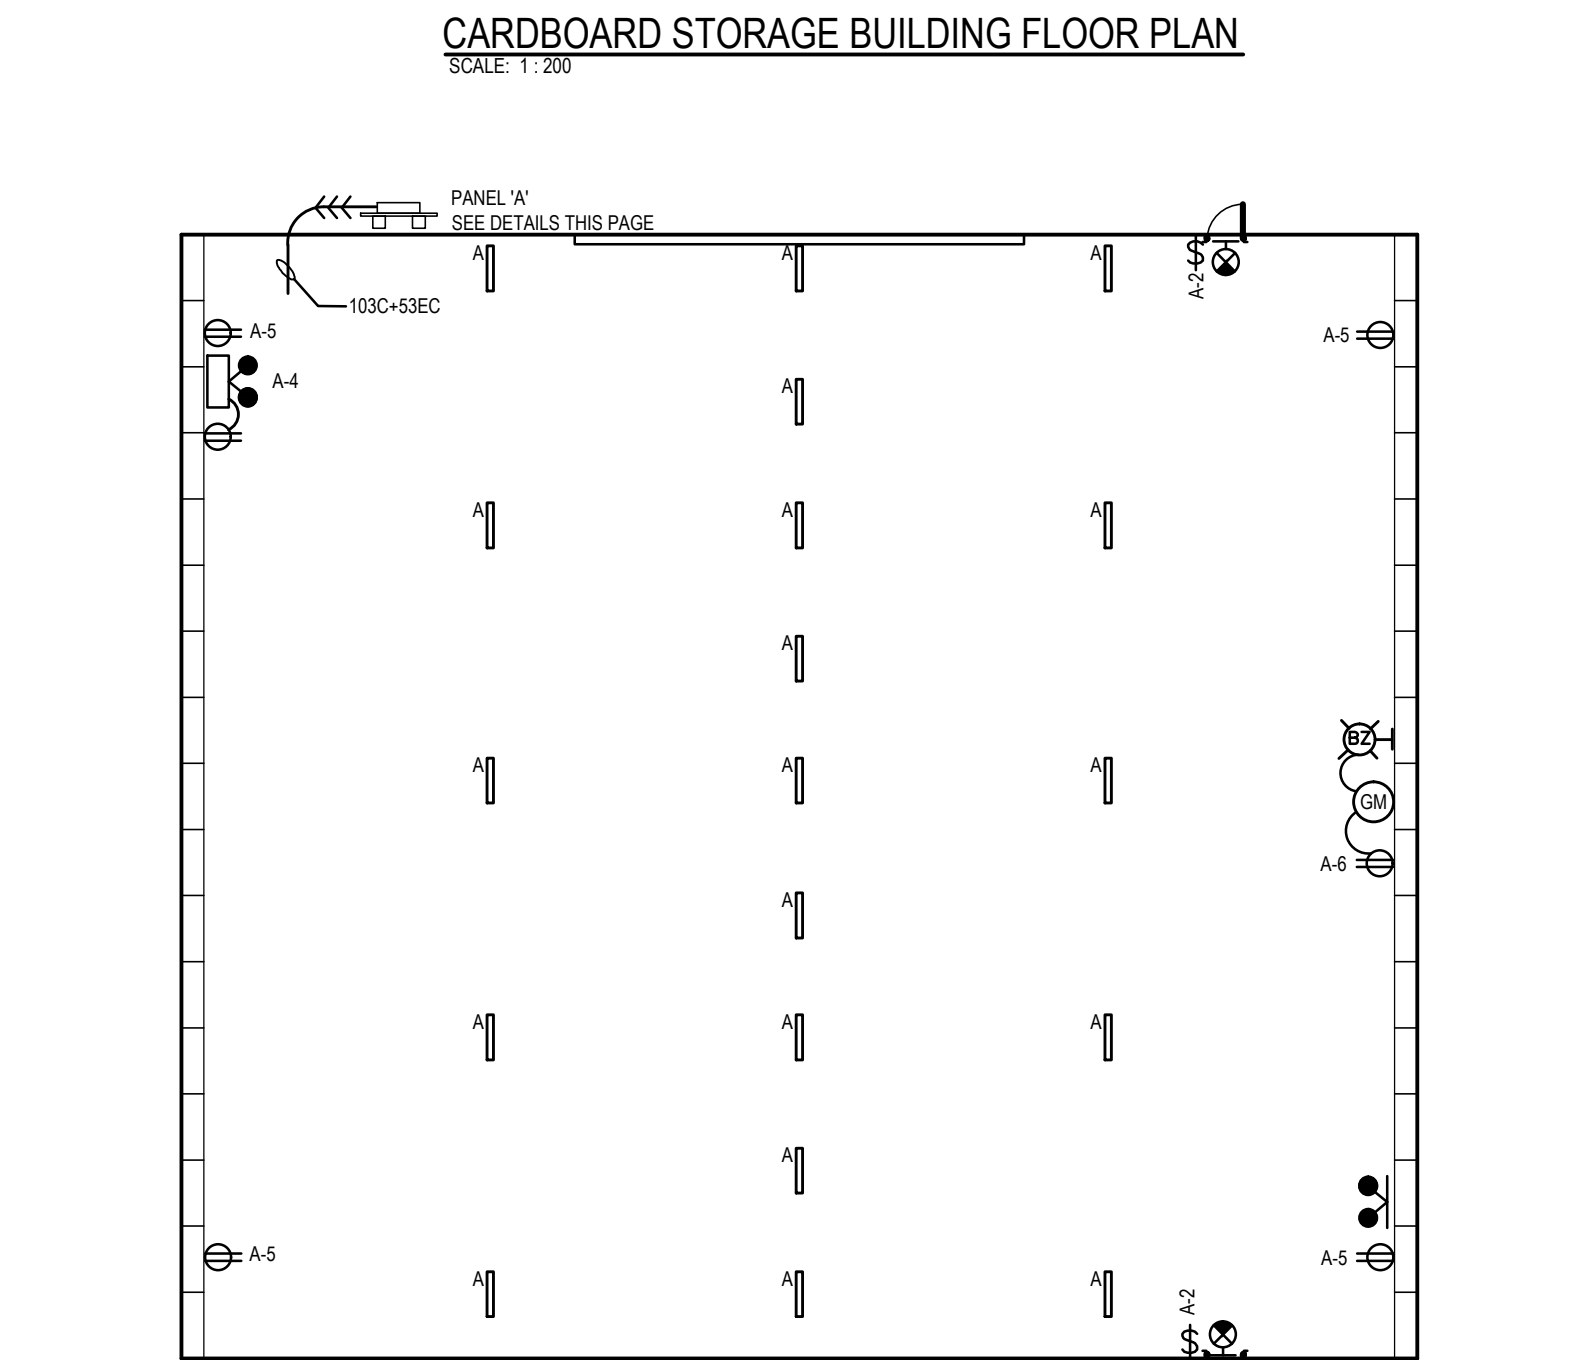
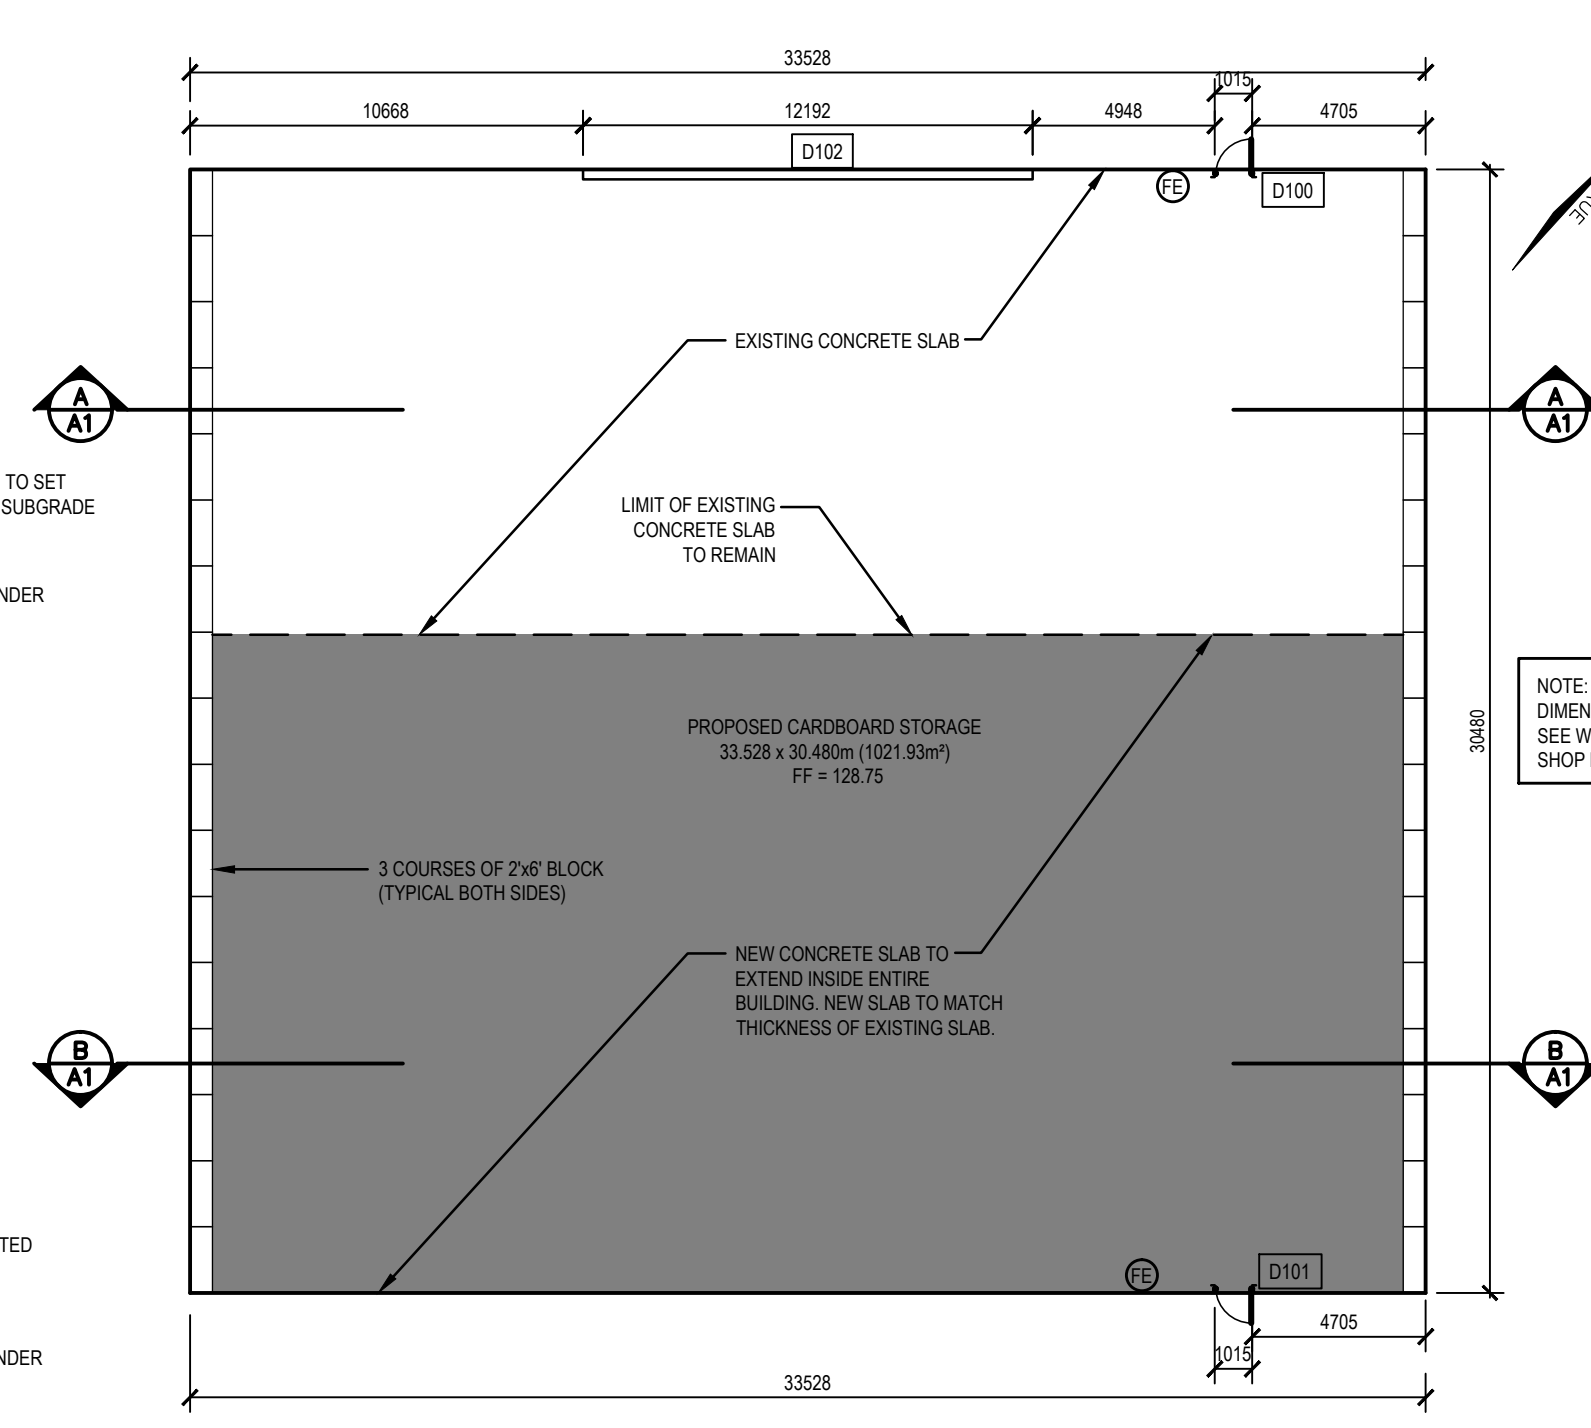


DOOR, FRAME AND HARDWARE SCHEDULE																				
DOOR No.	SIZE W x H x THICKNESS	DOOR					FRAME				REMARKS	HINGES 1 1/2 PAIR	CLOSURE	PASSAGE SET	EXIT DEVICE	LOCK SET	WEATHER STRIPPING	THRESHOLD	DOOR STOP	REMARKS
		TYPE	MAT'L	FIN	GLASS	FIRE RAT'G	TYPE	MAT'L	FIN	FIRE RAT'G										
100	914 x 2134	A	HM	PT	YES	---	1	HM	PT	---	INSULATED EXTERIOR DOOR & FRAME (GLAZED)	YES	YES	NONE	YES	---	YES	YES	NO	KICK PLATE
101	914 x 2134	A	HM	PT	YES	---	1	HM	PT	---	INSULATED EXTERIOR DOOR & FRAME (GLAZED)				YES	---	YES	YES	NO	KICK PLATE
102	5486 x 12192	B	STL	PT	---	---	---	STLG	---	---	PRE-FINISHED ROLL UP DOOR	---	---	---	---	---	---	---	---	---

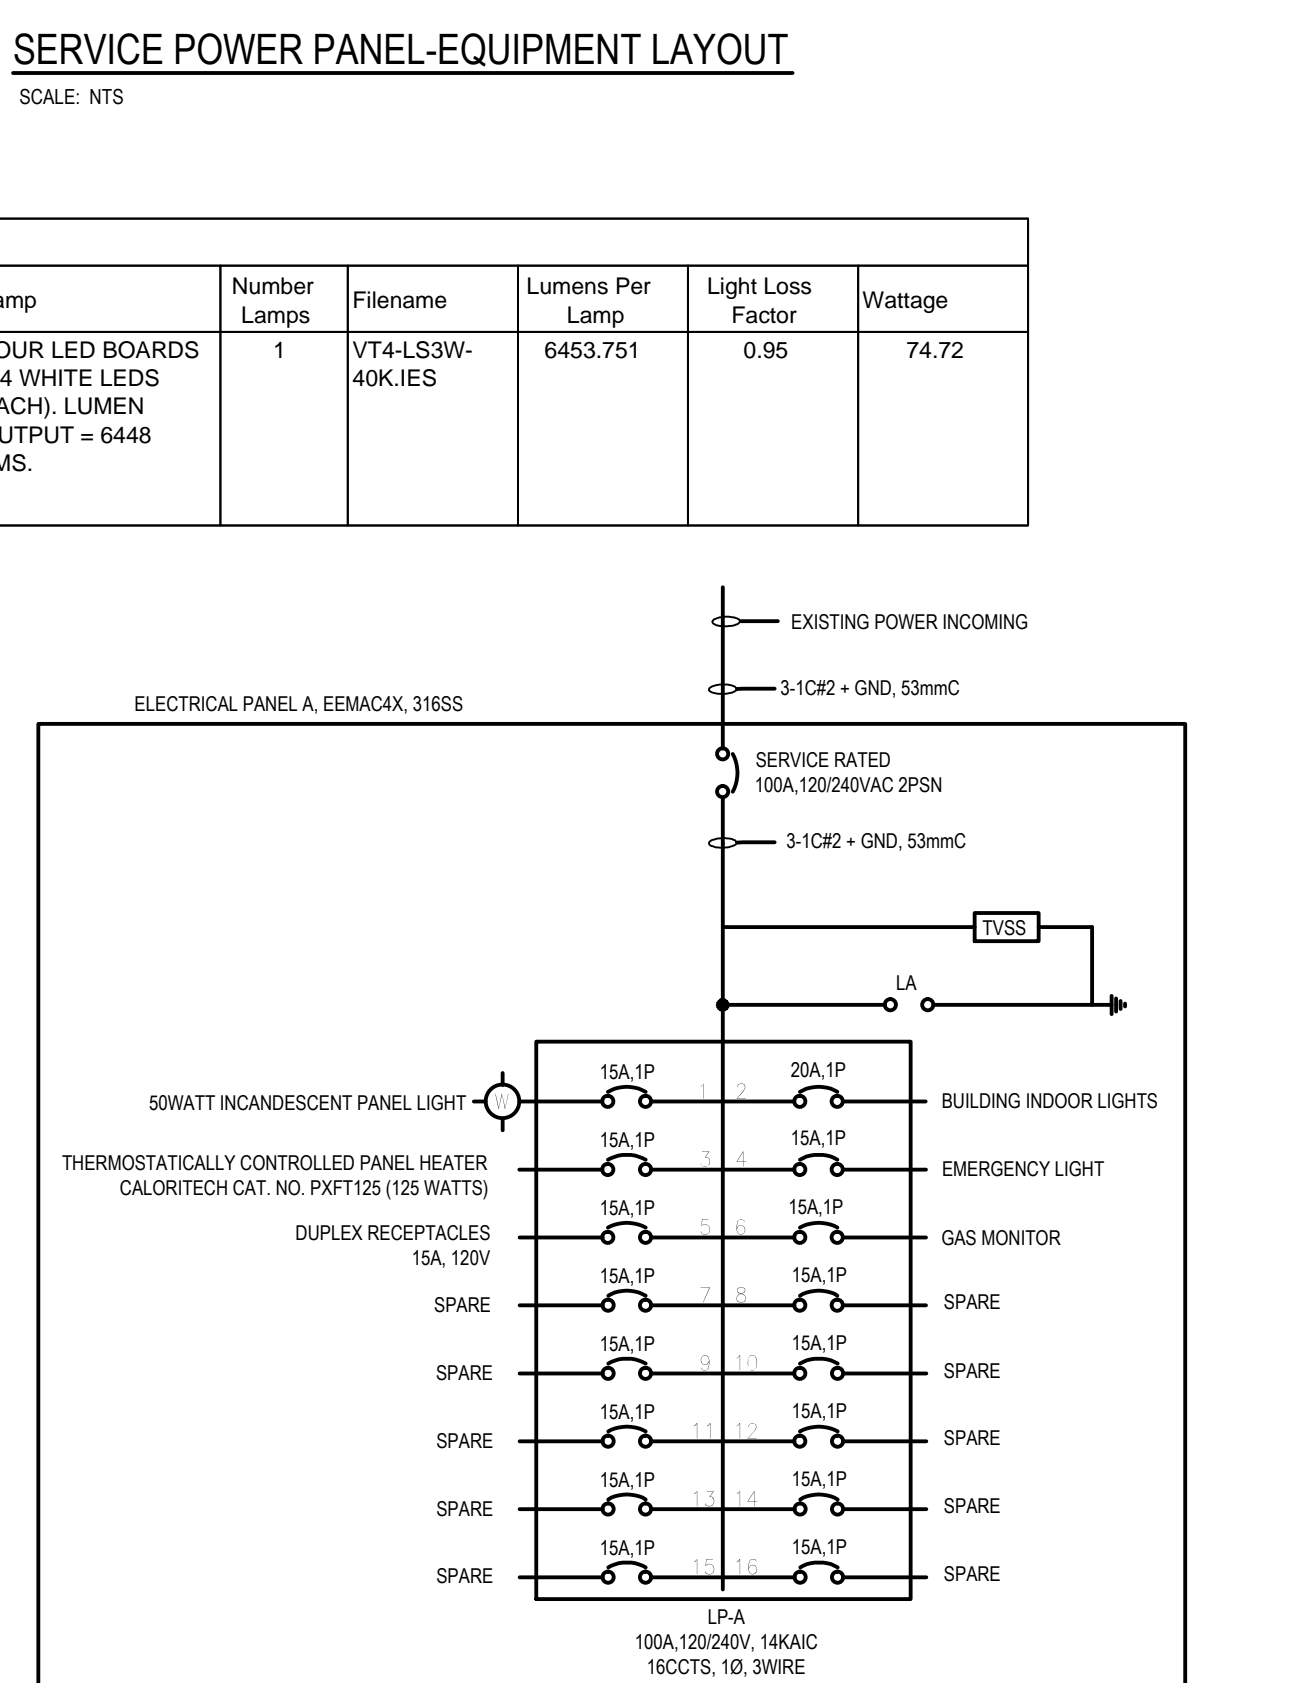

Luminaire Schedule									
Symbol	Label	Quantity	Manufactur er	Catalog Number	Description	Lamp	Number Lamps	Filename	Lumens Per Lamp
	A	19	STANPRO LIGHTING SYSTEMS INC. DORVAL, QUEBEC	VT4-LS3W/40K	STANPRO INDOOR LED VAPORPROOF LUMINAIRE WITH SPECULAR INTERIOR AND FROSTED LENS	FOUR LED BOARDS (44 WHITE LED EACH), LUMEN OUTPUT = 6448 LMS.	1	VT4-LS3W- 40K.IES	6453.751

THE LUMINAIRES COME WITH HAND MOUNTING BRACKET AND A PAIR OF HOOKS AS ACCESSORIES.

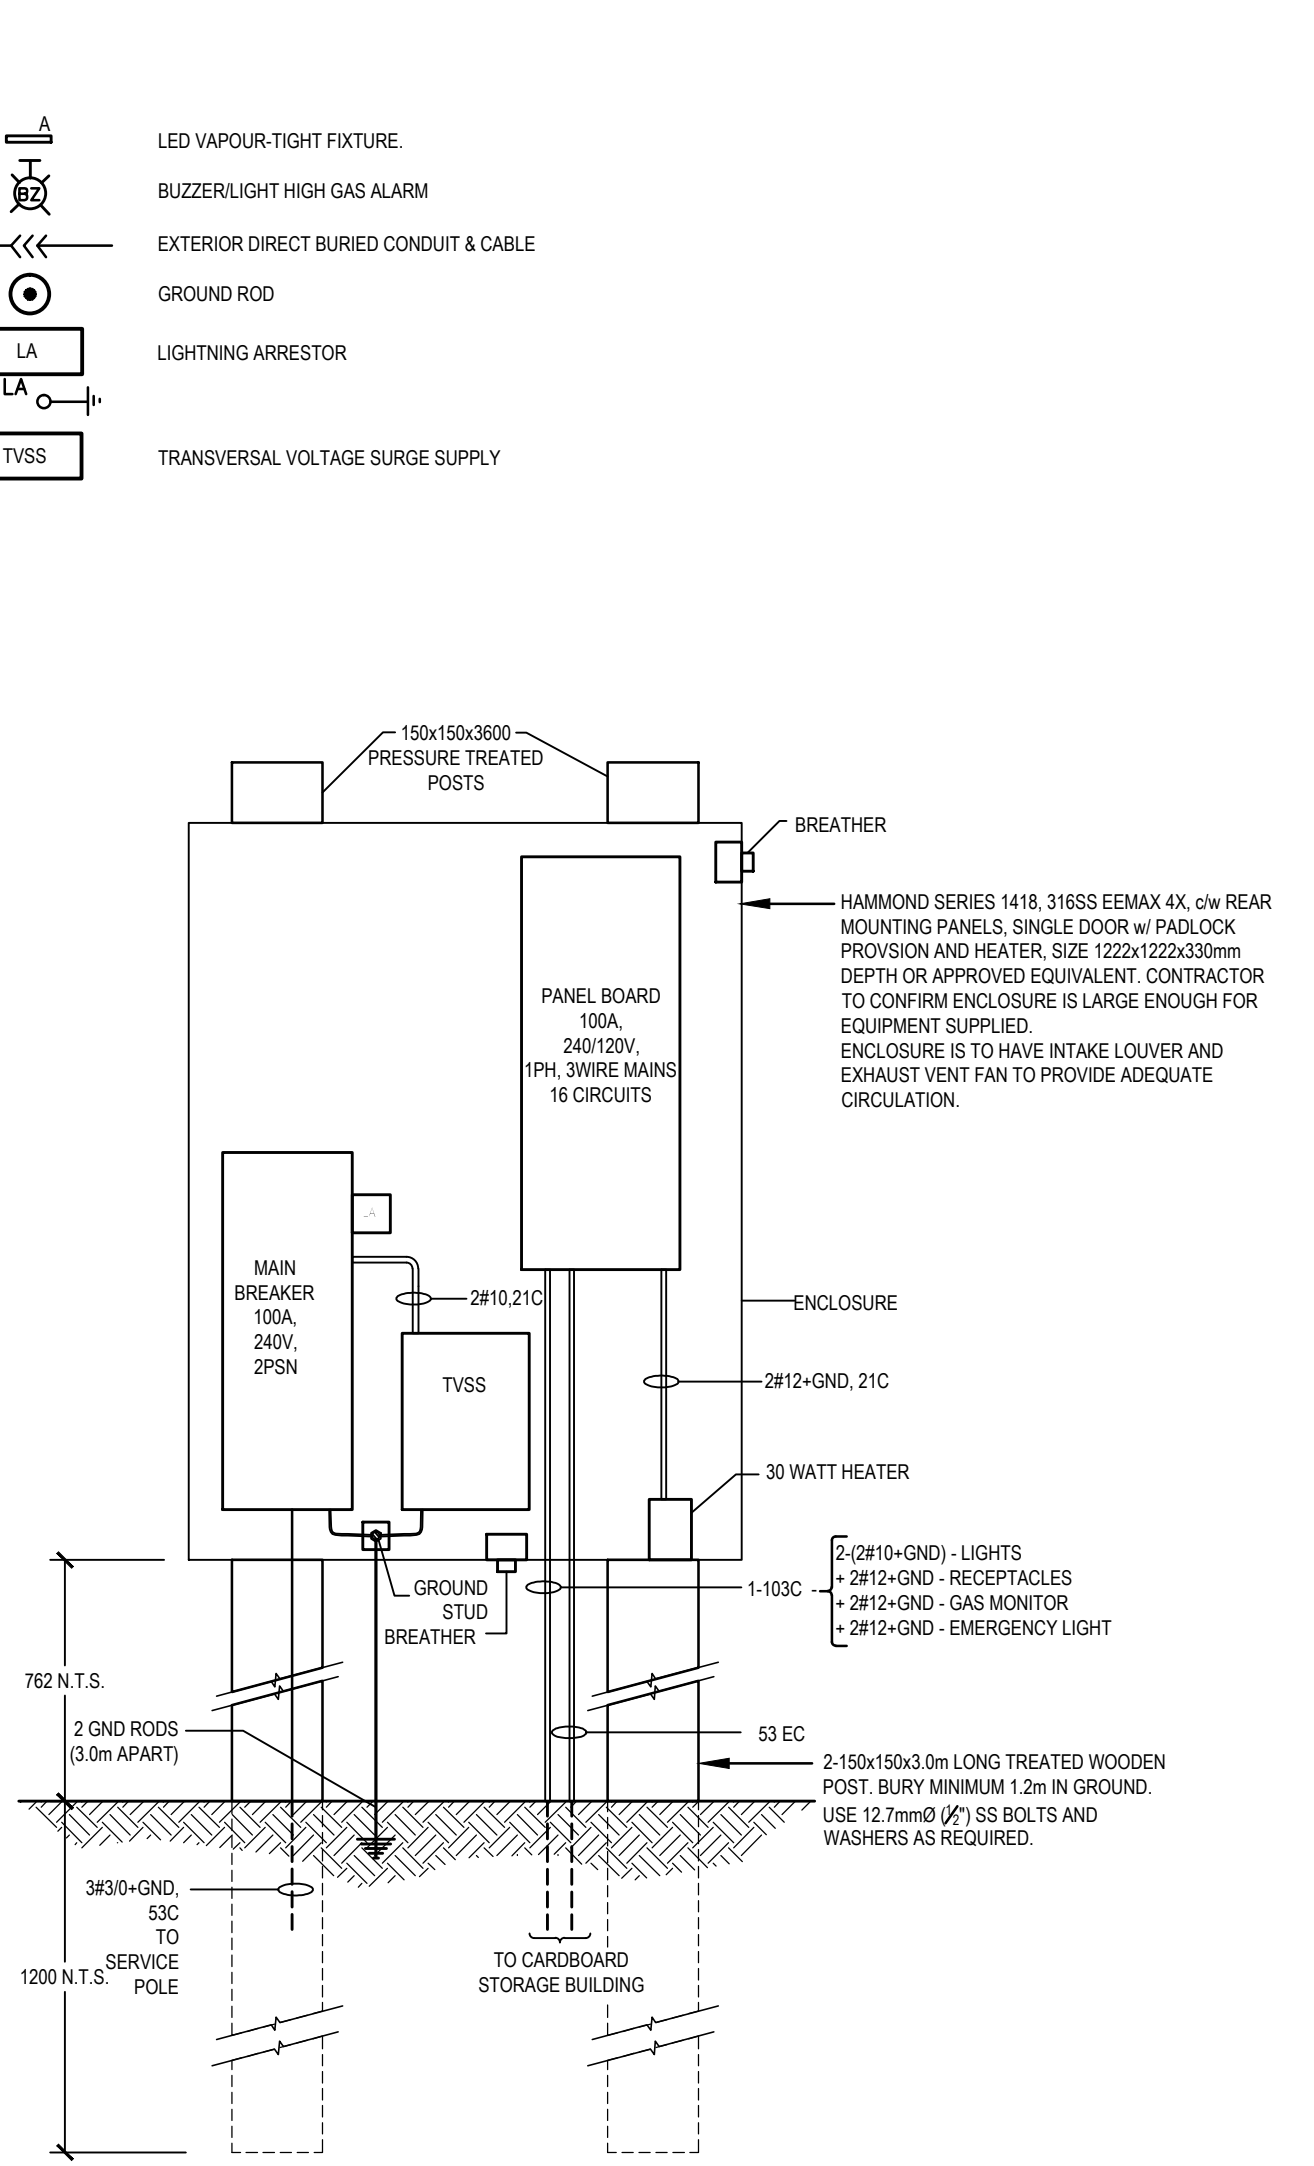

APPROVED ☐ REFUSED ☐

THIS _____ DAY OF _____, 20____

DERRICK MOODIE, MANAGER
DEVELOPMENT REVIEW, RURAL SERVICES



OWEN SOUND (ONTARIO) CANADA MKK 6W2
TEL: 519-376-7612 FAX: 519-376-8008 WWW.WSPGROUP.COM

WASTE MANAGEMENT

CARDBOARD STORAGE BUILDING
FLOOR PLAN AND DETAILS

WEST CARLETON ENVIRONMENTAL CENTRE

DWN BY: T C G DATE: APRIL 17, 2015
CHK BY: P S B SCALE: AS SHOWN

WASTE MANAGEMENT OF CANADA CORPORATION
DRAWING NO.

131-19416-00 - A1

DRAWING
A1